


| DATE | REV | AMENDMENT | BY | CHKD |
|---------|-----|--------------|-------|-------|
| 8.02.11 | 1 | TENDER ISSUE | R.Fox | R.Fox |
| | | | | |
| | | | | |
| | | | | |

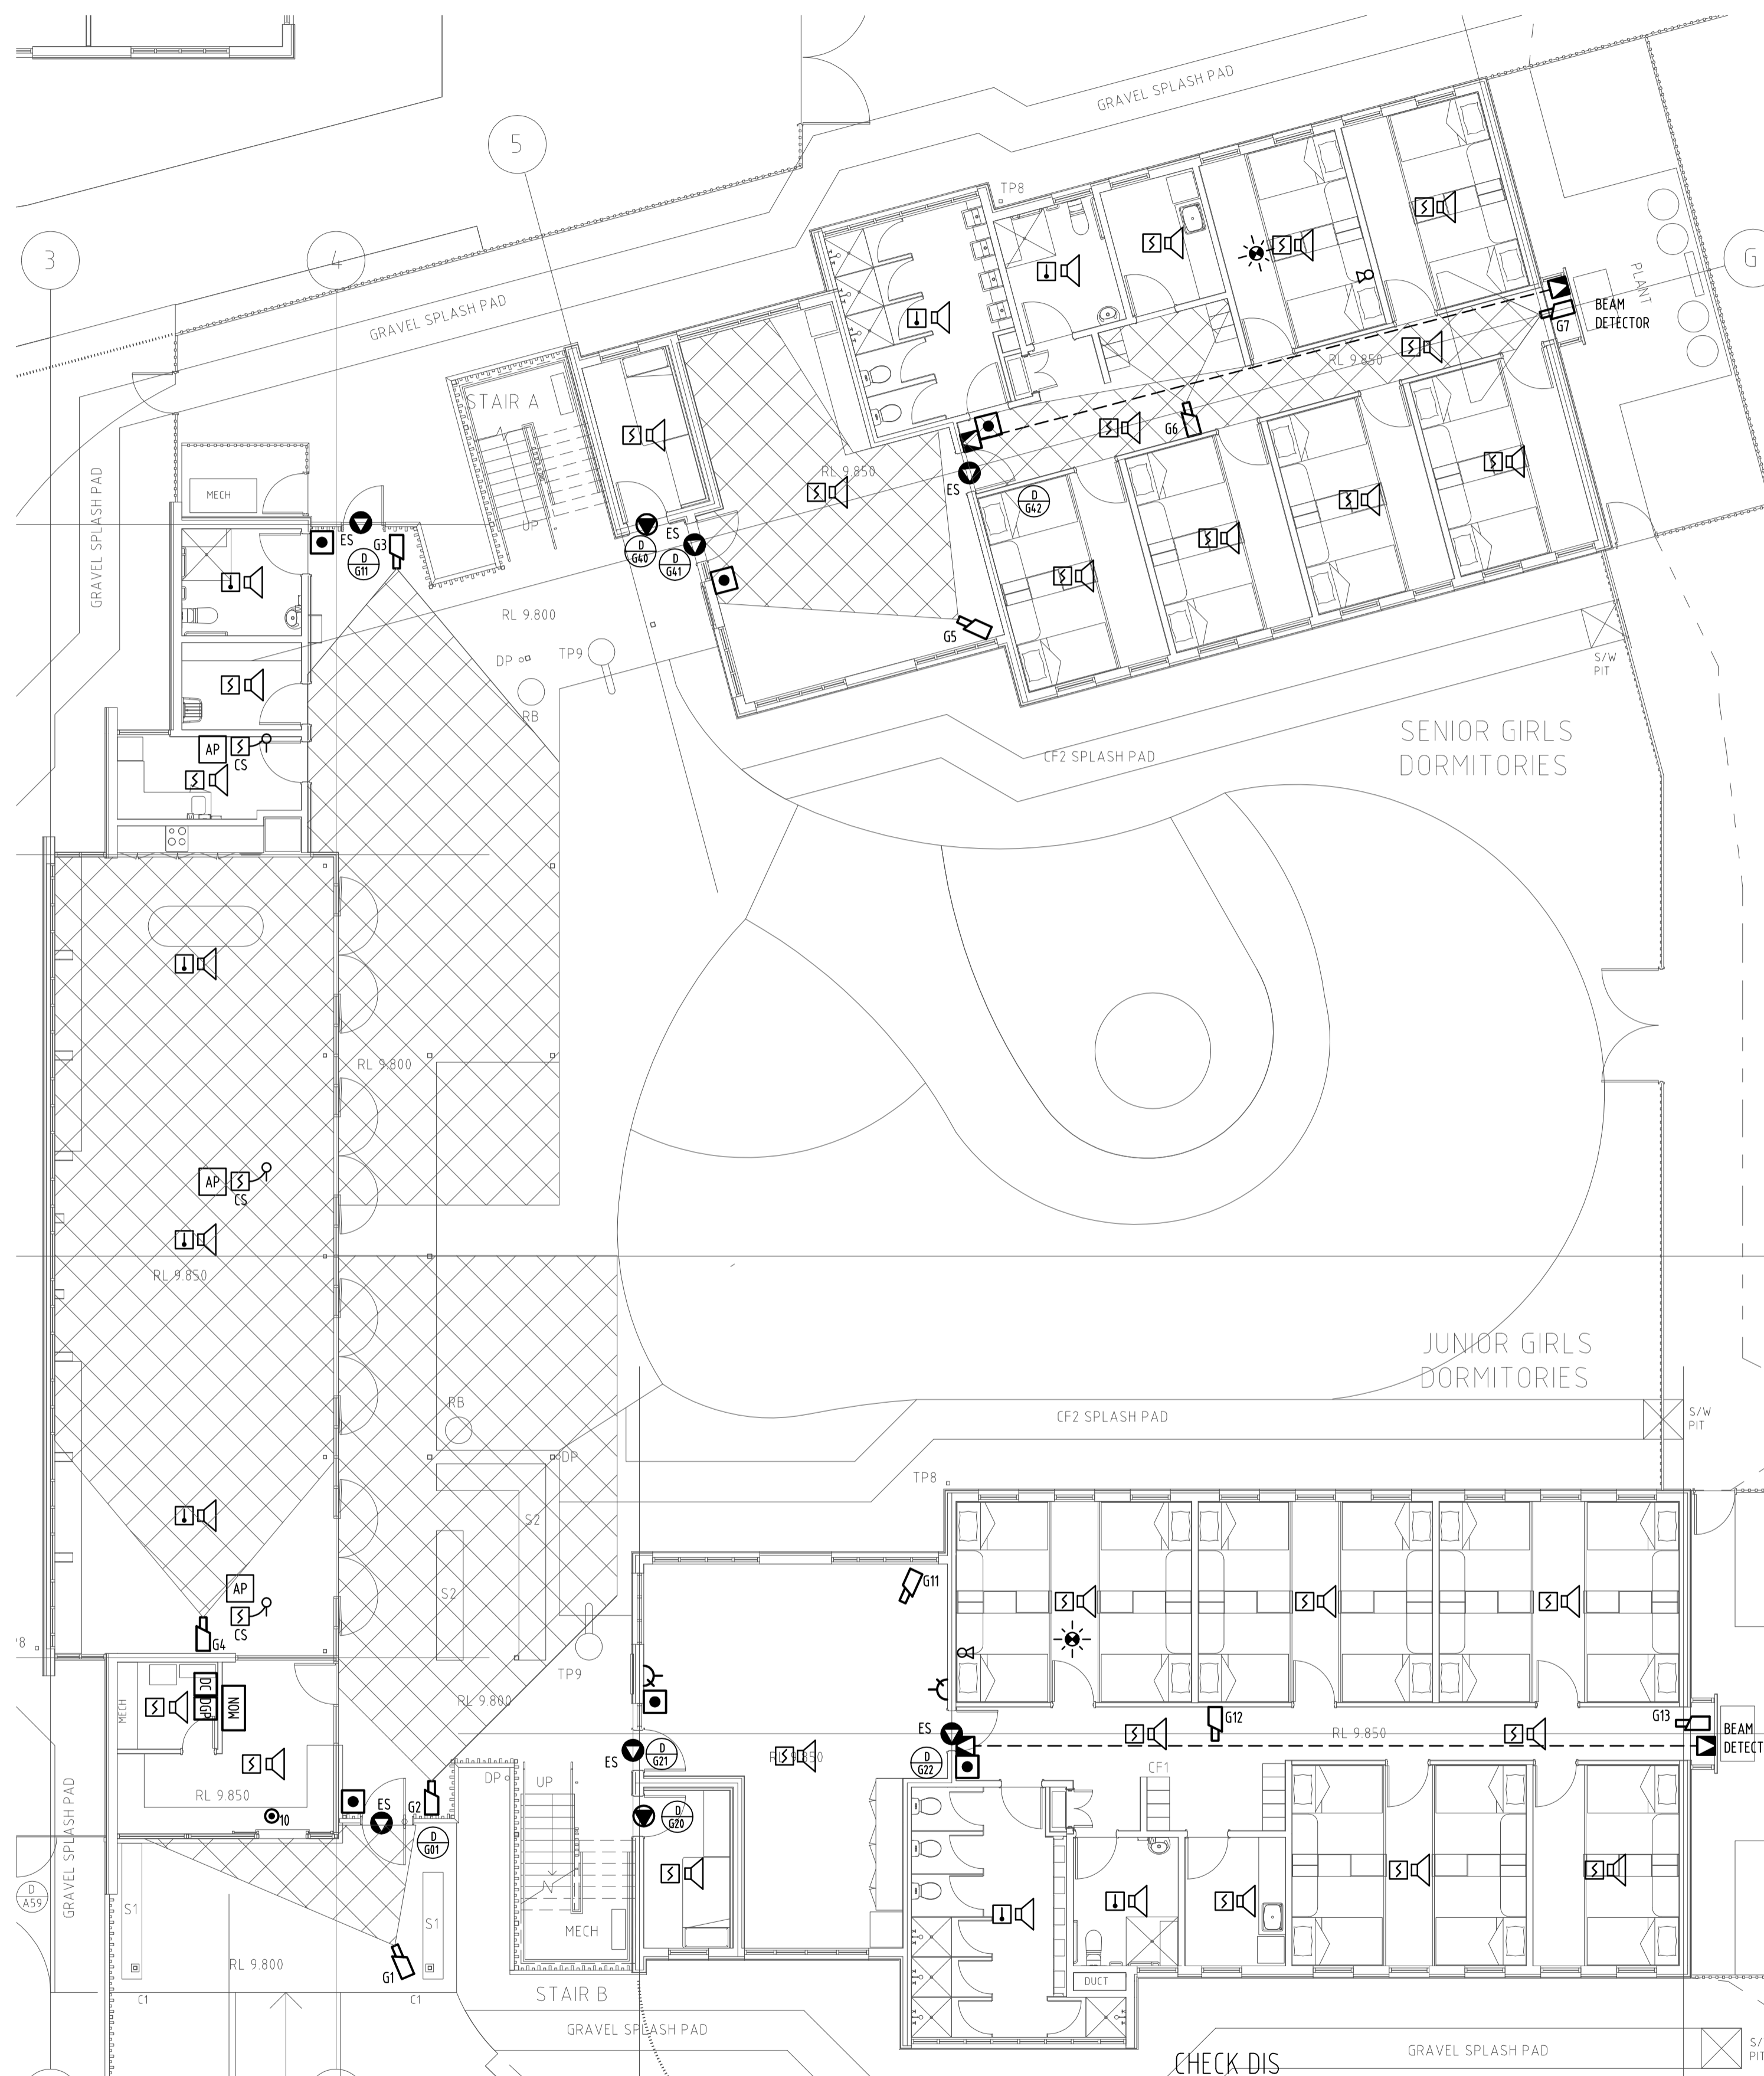


GROUND FLOOR



FIRST FLOOR NORTH

DOOR LOCK SCHEDULE

| DOOR | LOCATION | LOCK | CARD READER | BREAK GLASS | OPEN BUTTON | REMOTE UNLOCK | MONITOR | COMMENTS |
|--------------|------------------------|--------|-------------|-------------|-------------|---------------|----------------------------|--|
| G01 | ENTRANCE | STRIKE | | INSIDE | | RECEPTION | WHEN OPENED - OPEN TO LONG | UNLOCK ON FIRE ALARM - TIME SCHEDULE CONTROL |
| G11 | REAR ENTRANCE | STRIKE | | INSIDE | | | WHEN OPENED - OPEN TO LONG | UNLOCK ON FIRE ALARM |
| G21-41-61-81 | DORM ENTRANCE | STRIKE | | INSIDE | | RECEPTION | WHEN OPENED - OPEN TO LONG | UNLOCK ON FIRE ALARM - TIME SCHEDULE CONTROL |
| G22-42-62-82 | DORM CORRIDOR ENTRANCE | STRIKE | | INSIDE | | RECEPTION | WHEN OPENED - OPEN TO LONG | UNLOCK ON FIRE ALARM - TIME SCHEDULE CONTROL |
| G20-40-60-80 | SLEEP OUT ROOM | | | | | | WHEN OPENED | |

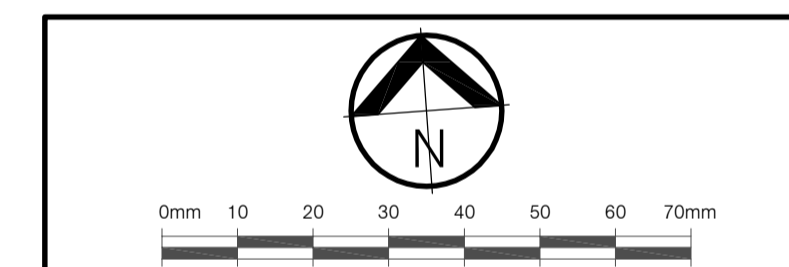

Level 1, 116 Grafton Street
 GPO Box 5107
 Cairns Q 4870 Australia
 T +61 7 4031 1707
 F +61 7 4041 5851
 E admin@fabarchitects.com.au
 W www.fabarchitects.com.au

**fisher architects
 buttrose**

| REFERENCE COORDINATION DRAWINGS | | | |
|---------------------------------|-----------------|-----|------|
| DESCRIPTION | DRAWING NO. | REV | CHKD |
| GIRLS ACCOM - GROUND FLOOR | 3278-CD-AR-0220 | 2 | NKG |
| GIRLS ACCOM - FIRST FLOOR | 3278-CD-AR-0221 | 2 | NKG |

WSP LincolnScott

Suite 6, 22 Lily Street
 PO Box 6504 North Cairns
 Queensland 4870 Australia


Telephone 61 7 4051 2299
 Facsimile 61 7 4051 2292
 cairns@wspilcolnscott.com

PROJECT
**WESTERN CAPE
 RESIDENTIAL CAMPUS
 TAMARIND ROAD, WEIPA**

CLIENT
 INDIGENOUS LAND CORPORATION

| | | | |
|------------|--|----------|-------|
| DATE | NOV 2010 | DRAWN | NKG |
| SCALE | 1:100 | CHECKED | R.Fox |
| SHEET SIZE | A1 | APPROVED | R.Fox |
| CAD FILE | P:\10011\Electrical\3278-T-EL-0304.dwg | | |

| TITLE | PROJECT NO. | DRAWING NO. | REVISION |
|--|-------------|-------------|----------|
| ELECTRICAL SERVICES STUDENT ACCOMMODATION FIRE AND SECURITY LAYOUT | 3278-T-EL- | 0304 | 1 |

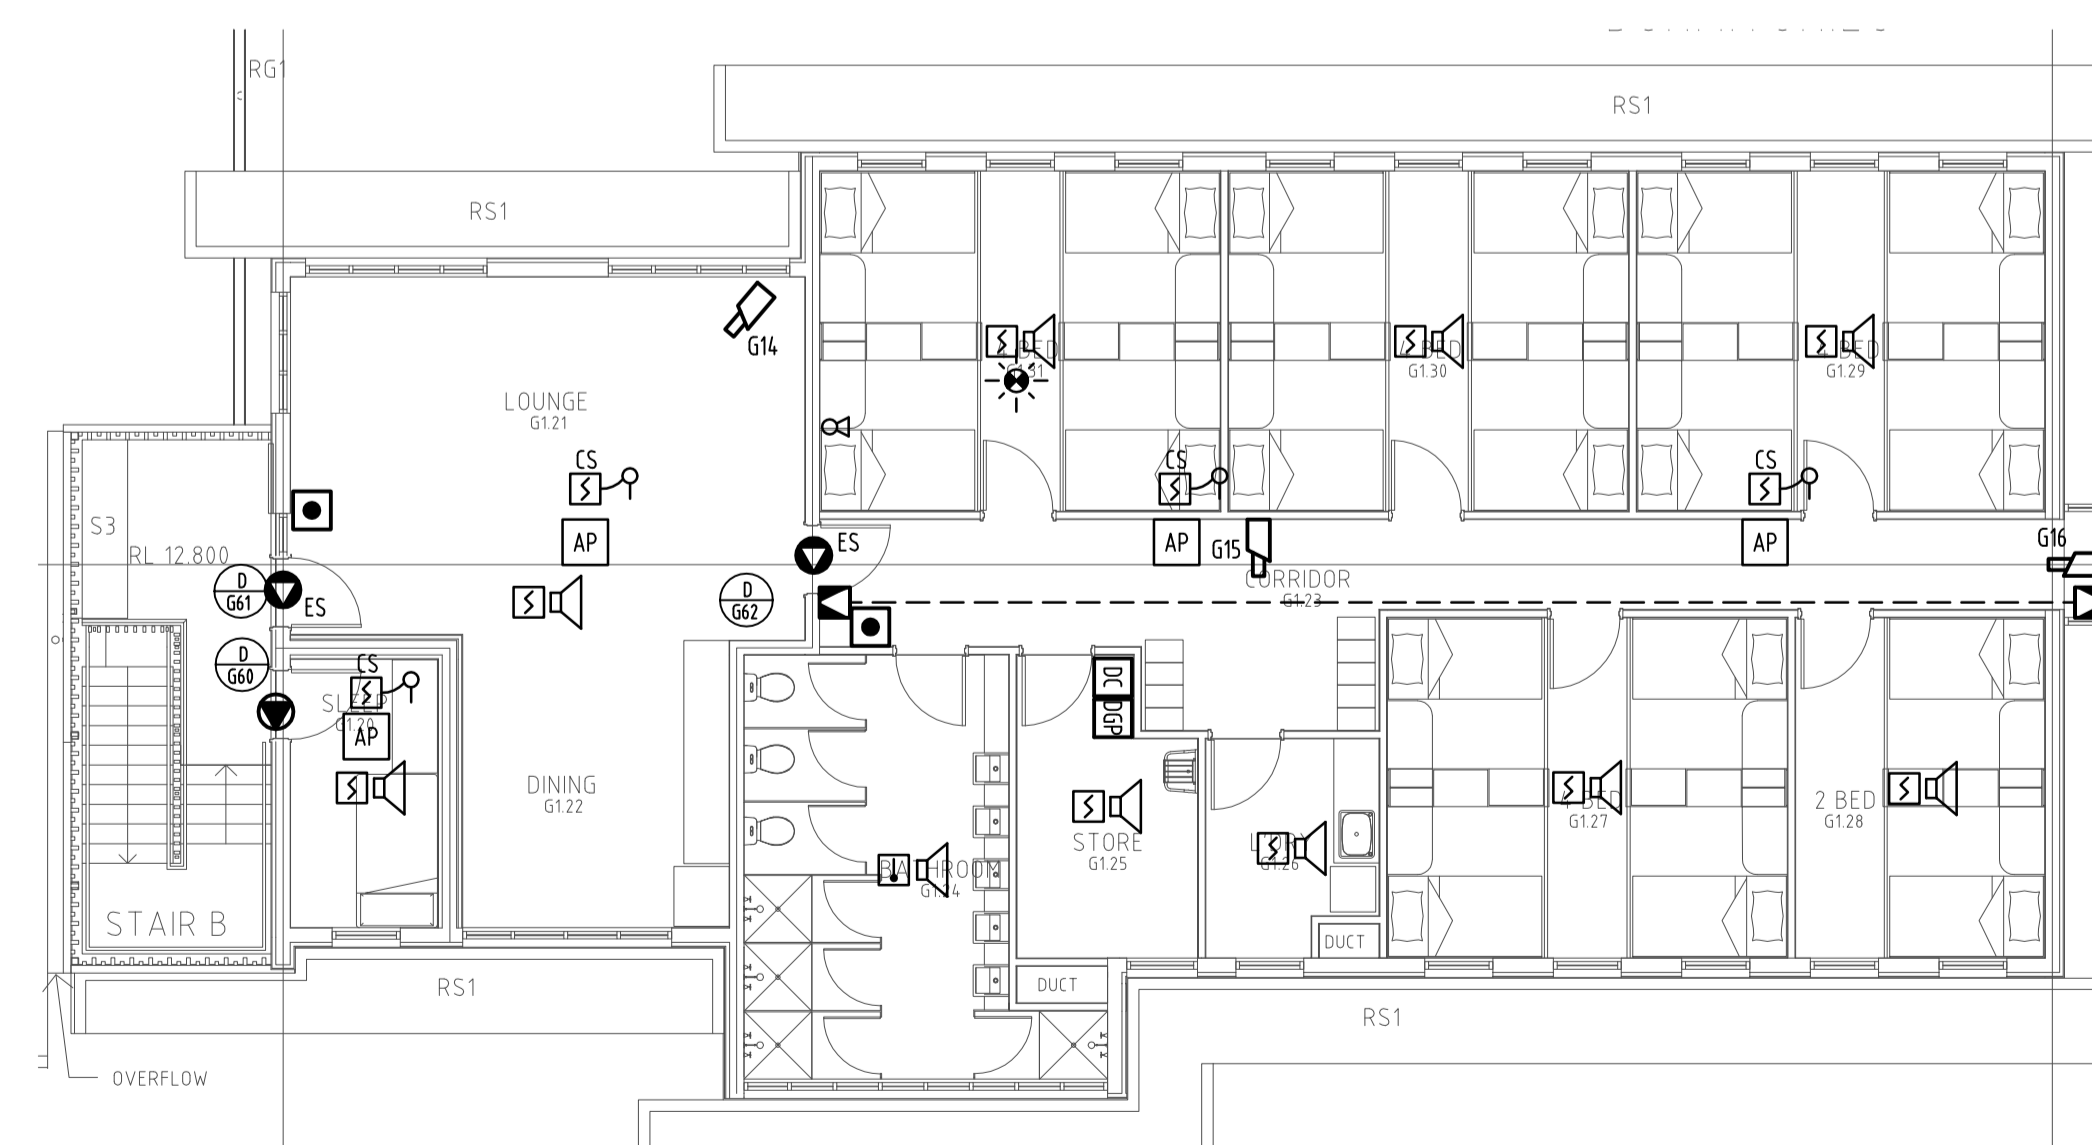

FIRST FLOOR SOUTH

**THIS DRAWING DETAILS THE
 GIRLS BLOCK - THE BOYS
 BLOCK IS A MIRRORED COPY**

TENDER